



REPUBLIC OF THE PHILIPPINES  
**ZAMBOANGA CITY WATER DISTRICT**  
PILAR STREET, ZAMBOANGA CITY

PROJECT TITLE:

# PROPOSED WELL EXPLORATION, TESTING AND DEVELOPMENT AT MERCEDES

PROJECT LOCATION: MERCEDES ZAMBOANGA CITY, PHILIPPINES



**SITE LOCATION MAP**

SCALE: NTS



**SITE DEVELOPMENT PLAN**


SCALE: NTS

Original Lot Title:  
Lot no.: Lot 2, Pcs-09-000234  
Title no.: T-57, 884  
Area: 40,464 sqm


	<table border="1"> <thead> <tr> <th>REV.</th> <th>DATE</th> <th>BY</th> <th>DESCRIPTION</th> </tr> </thead> <tbody> <tr><td> </td><td> </td><td> </td><td> </td></tr> <tr><td> </td><td> </td><td> </td><td> </td></tr> <tr><td> </td><td> </td><td> </td><td> </td></tr> <tr><td> </td><td> </td><td> </td><td> </td></tr> </tbody> </table>	REV.	DATE	BY	DESCRIPTION																	<p>PROJECT: PROPOSED WELL EXPLORATION, TESTING AND DEVELOPMENT AT MERCEDES</p>	<p>ISSUED BY:  <b>DARRELL B. SALAZAR</b> ASSOCIATE ARCHITECT AND DESIGNER</p>	<p>PREPARED BY:  <b>VERLIN ANN L. LORA</b> SENIOR CIVIL ENGINEER, PE, DESIGNER</p>	<p>REVIEWED BY:  <b>REX D. SALE, JR.</b> REGISTERED PROFESSIONAL ENGINEER</p>	<p>APPROVED BY:  <b>EDITO M. BALTISTA, JR.</b> REGISTERED PROFESSIONAL ENGINEER</p>	<p>RECOMMENDED PROJECT IMPLEMENTATION:  <b>MARLI ACOSTA-DE FIESTA</b> REGISTERED PROFESSIONAL ENGINEER FOR TECHNICAL SURVEY GROUP</p>	<p>APPROVED FOR PROJECT IMPLEMENTATION:  <b>REYNALDO R. CABILIN</b> REGISTERED PROFESSIONAL ENGINEER</p>	<p>SHEET NO. 1</p>
	REV.	DATE	BY	DESCRIPTION																									
<p>SHEET COMMENT: AS INDICATED</p>	<p>DATE:  </p>	<p>SCALE:  </p>	<p>PROJECT NO.  </p>	<p>DATE OF ISSUE:  </p>	<p>DATE OF REVISION:  </p>	<p>DATE OF APPROVAL:  </p>	<p>DATE OF APPROVAL:  </p>	<p>DATE OF APPROVAL:  </p>	<p>DATE OF APPROVAL:  </p>																				





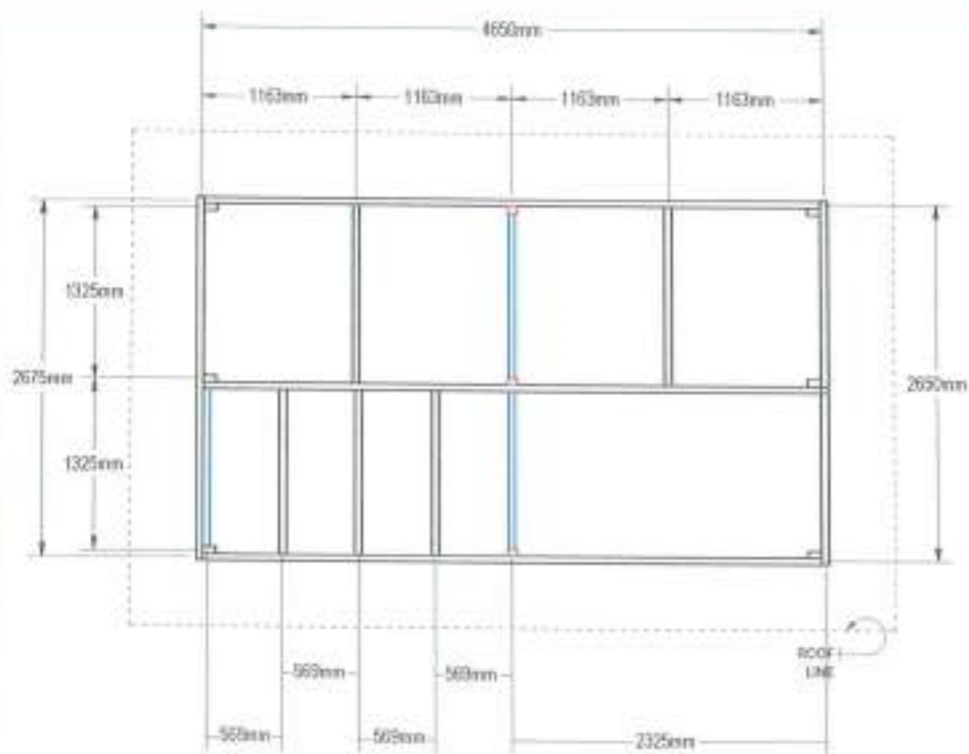




PLAN  
SCALE 1/8" = 1'-0"

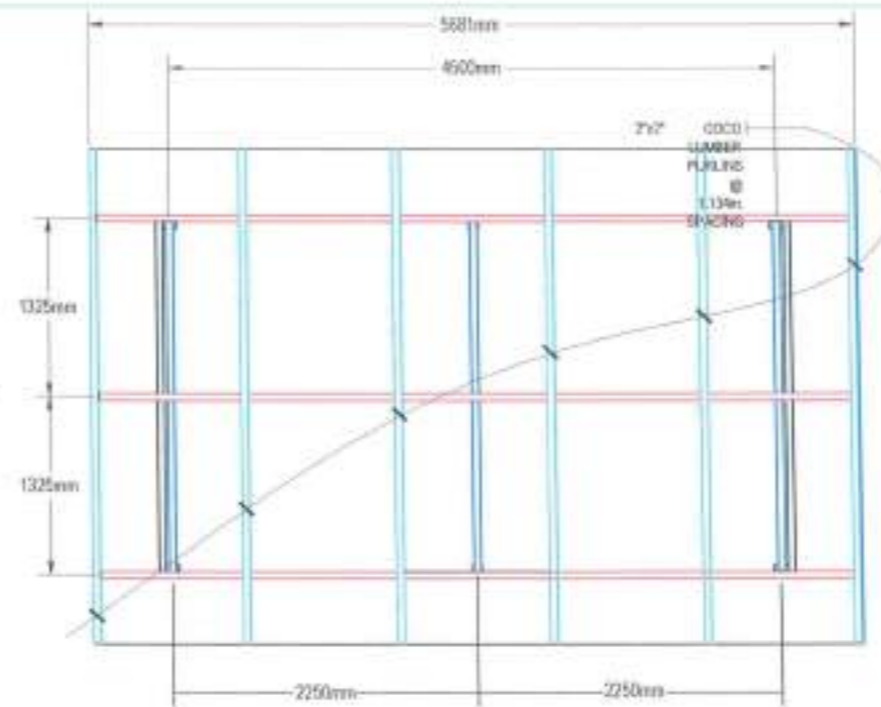

ROOF FRAMING PLAN  
SCALE 1/8" = 1'-0"



PERSPECTIVE

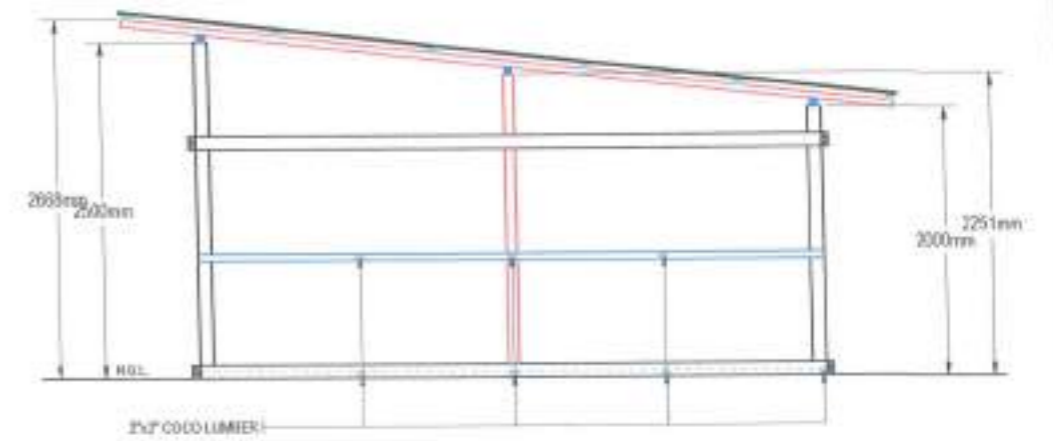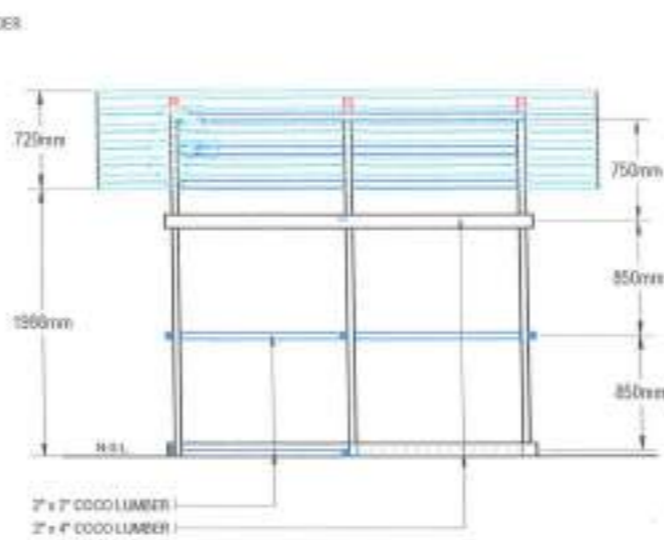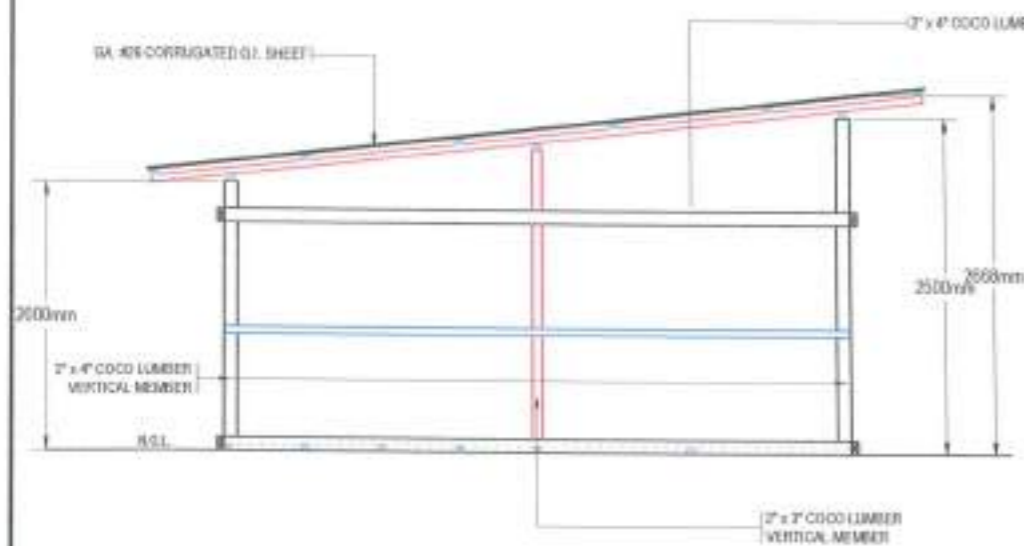

TEMPORARY FACILITY  
SCALE NTS

	REV.	DATE	BY	DESCRIPTION	PROJECT:	DRAWN BY:	DESIGNED BY:	REVIEWED BY:	SUBMITTED BY:	PROJECT MANAGER / PROJECT IMPLEMENTATION:	APPROVED FOR PROJECT IMPLEMENTATION:	SHEET NO.
					PROPOSED WELL EXPLORATION, TESTING AND DEVELOPMENT AT MERCEDOS	DARRELL B. SALARITAN ASSOCIATE ARCHITECT (AIA-REGISTERED)	VERLIN ANN L. LORBA ARCHITECTURE, INC. DESIGNER	BEX D. SALE, JR. REGISTERED ARCHITECT - DESIGNER	EDITO M. BAUTISTA, JR. REGISTERED ARCHITECT - DESIGNER	MARLI ACOSTA / DE FIESTA REGISTERED ARCHITECT - DESIGNER	REYNALDO K. CABILIN REGISTERED ARCHITECT - DESIGNER	3