





PLAN
SCALE: 1:55M.

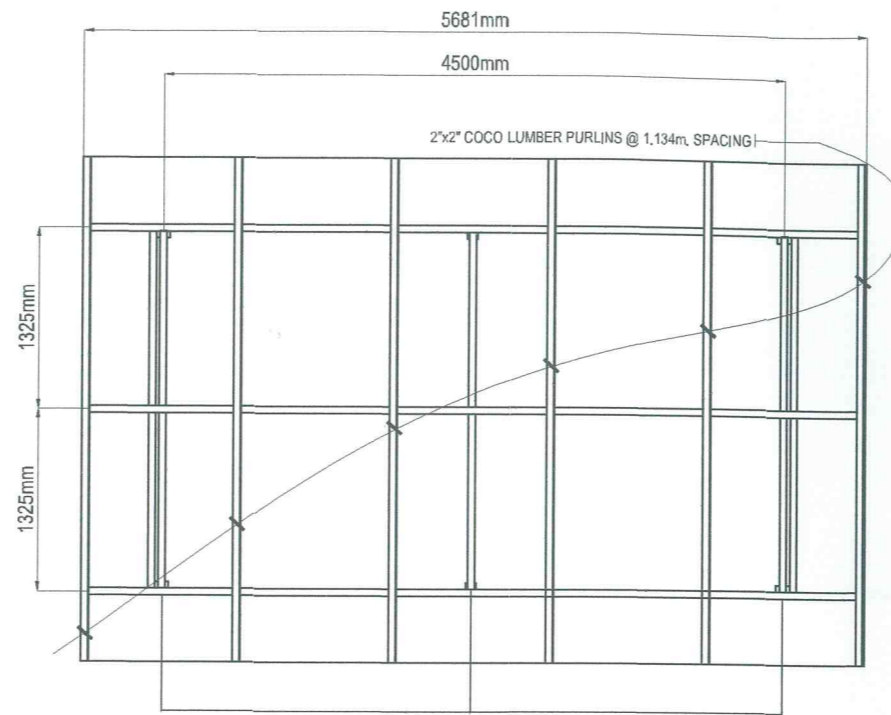

ROOF FRAMING PLAN
SCALE: 1:55M.





PERSPECTIVE

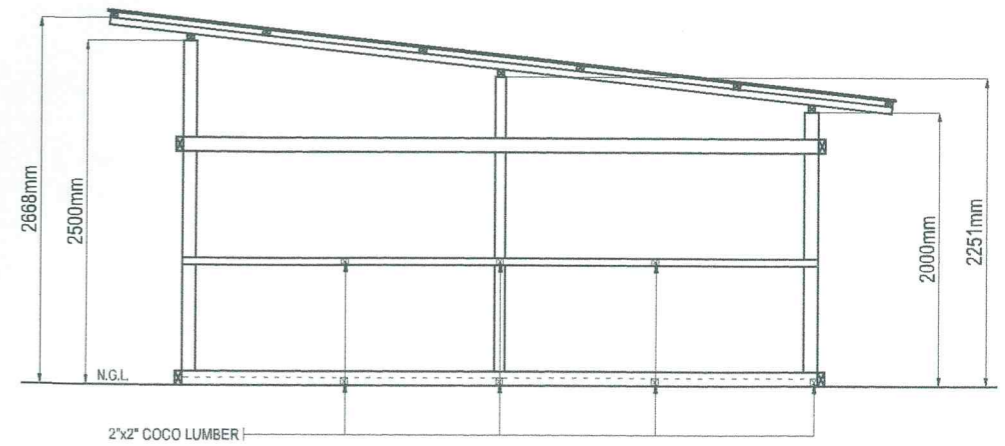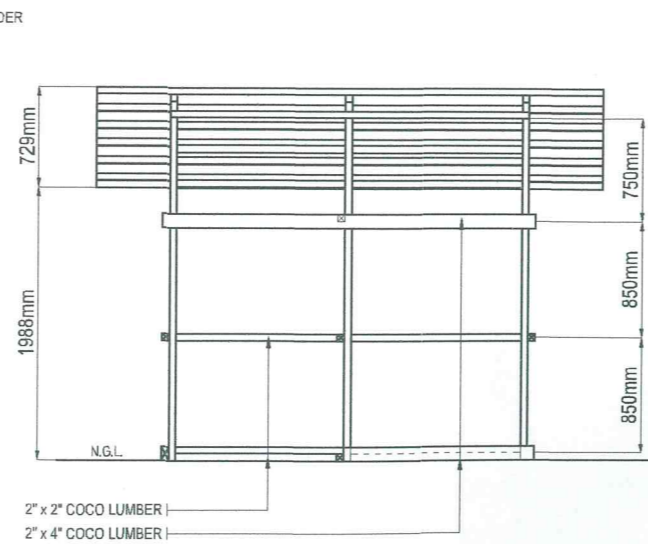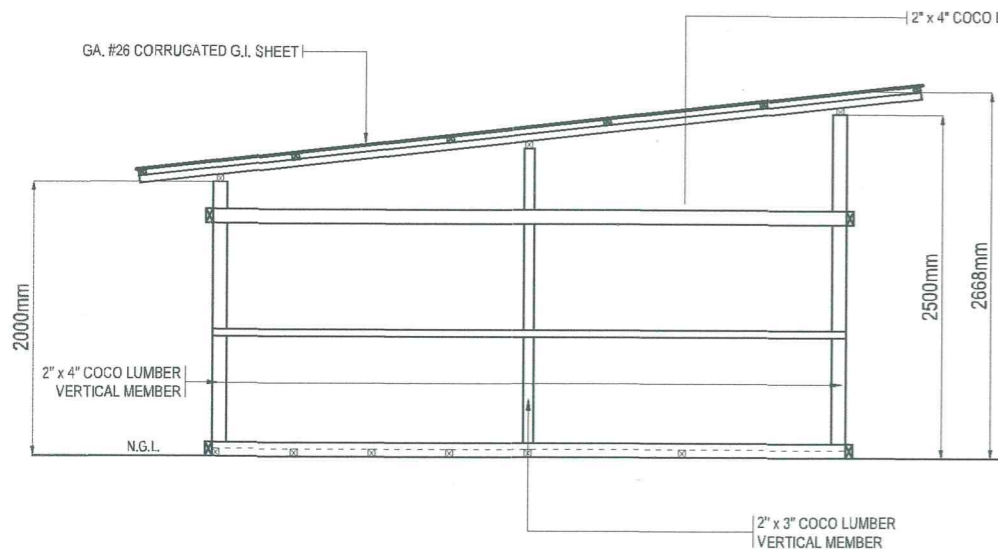


TEMPORARY FACILITY
SCALE: NTS

	REVISIONS REV. DATE BY DESCRIPTION				PROJECT: PROPOSED 300 CU. M. REINFORCED CONCRETE GROUND TANKS AT BALLUNO & BANDERA-DULUAN FOR DUMALON WATER SYSTEM	DRAWN BY: DARRELL B. SALARITAN SENIOR DRAFTSMAN - DESIGN DIVISION	PREPARED BY: BUNNY L. DAMPIOS SENIOR ENGINEER A - DESIGN DIVISION	REVIEWED BY: REX D. SALE, JR. SUPERVISING ENGINEER A - DESIGN DIVISION	SUBMITTED BY: EDITO M. BAUTISTA, JR. OIC - DESIGN DIVISION	RECOMMENDING PROJECT IMPLEMENTATION: MARLI ACOSTA - DE FIESTA APM - TECHNICAL SERVICES GROUP	APPROVED FOR PROJECT IMPLEMENTATION: REYNALDO R. CABILAN GENERAL MANAGER	SHEET NO. 56
	SHEET CONTENT: AS INDICATED											

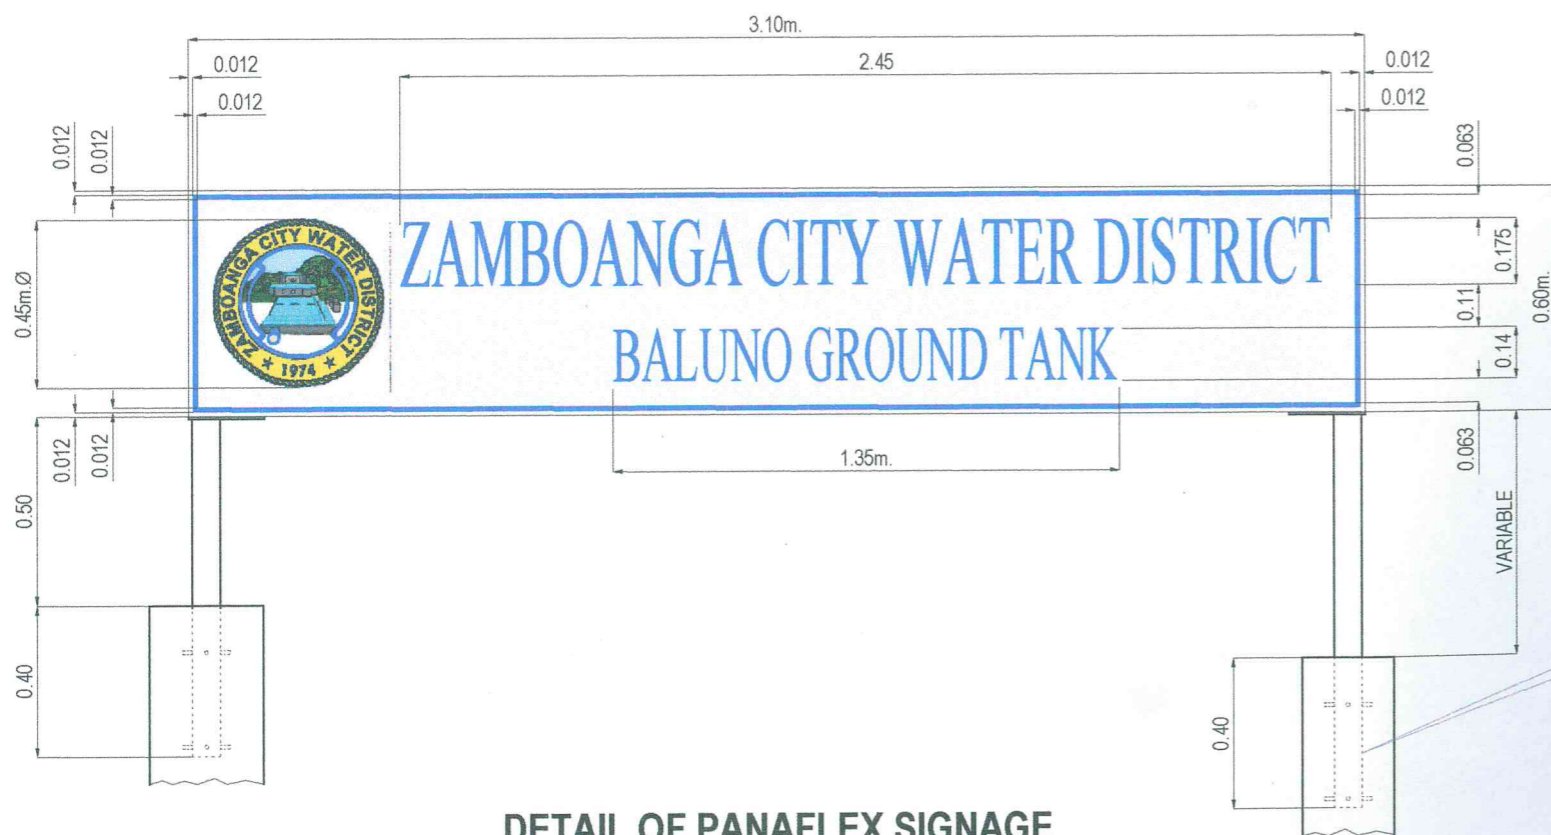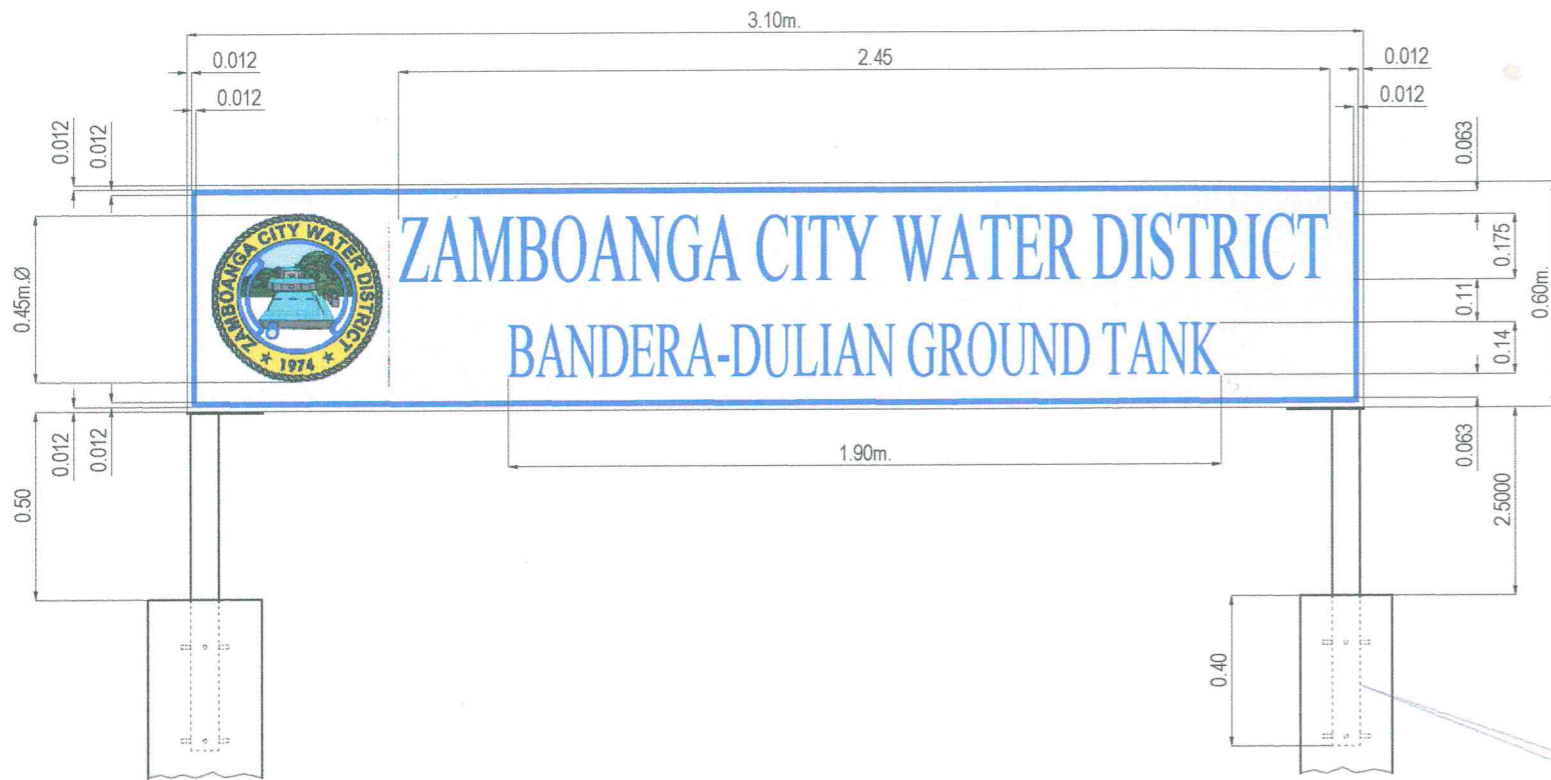

DETAIL OF PANAFLEX SIGNAGE

SCALE: 1:20 M.

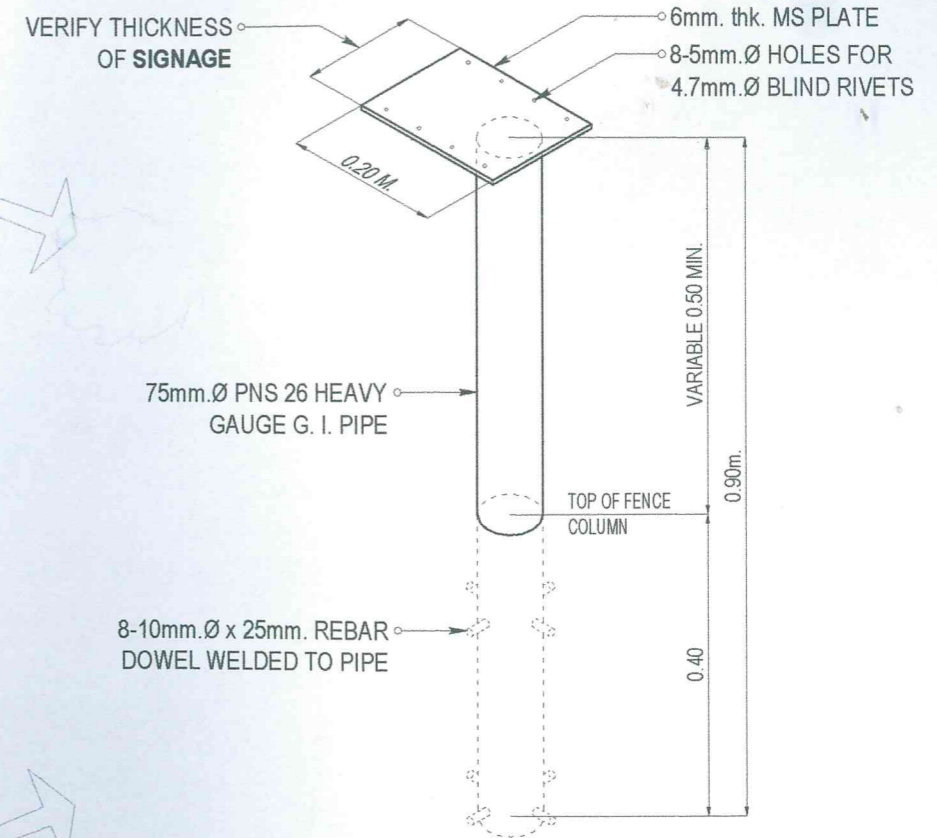

REVISIONS				PROJECT:	DRAWN BY:	PREPARED BY:	REVIEWED BY:	SUBMITTED BY:	RECOMMENDING PROJECT IMPLEMENTATION:	APPROVED FOR PROJECT IMPLEMENTATION:	SHEET NO.
REV.	DATE	BY	DESCRIPTION								
				PROPOSED 300 CU. M. REINFORCED CONCRETE GROUND TANKS AT BALUNO & BANDERA-DULIAN FOR DUMALON WATER SYSTEM	ARTHUR A. REYES PRINCIPAL DRAFTSMAN - DESIGN DIVISION	BUNNY L. DAMPIOS SENIOR ENGINEER A - DESIGN DIVISION	REX D. SALE, JR. SUPERVISING ENGINEER A - DESIGN DIVISION	EDITO M. BAUTISTA JR. D/C - DESIGN DIVISION	MARLI ACOSTA - DE FIESTA AGM - TECHNICAL SERVICES GROUP	REYNALDO R. CABILN GENERAL MANAGER	57
SHEET CONTENT:				AS INDICATED							