



TOP FLOOR PLAN

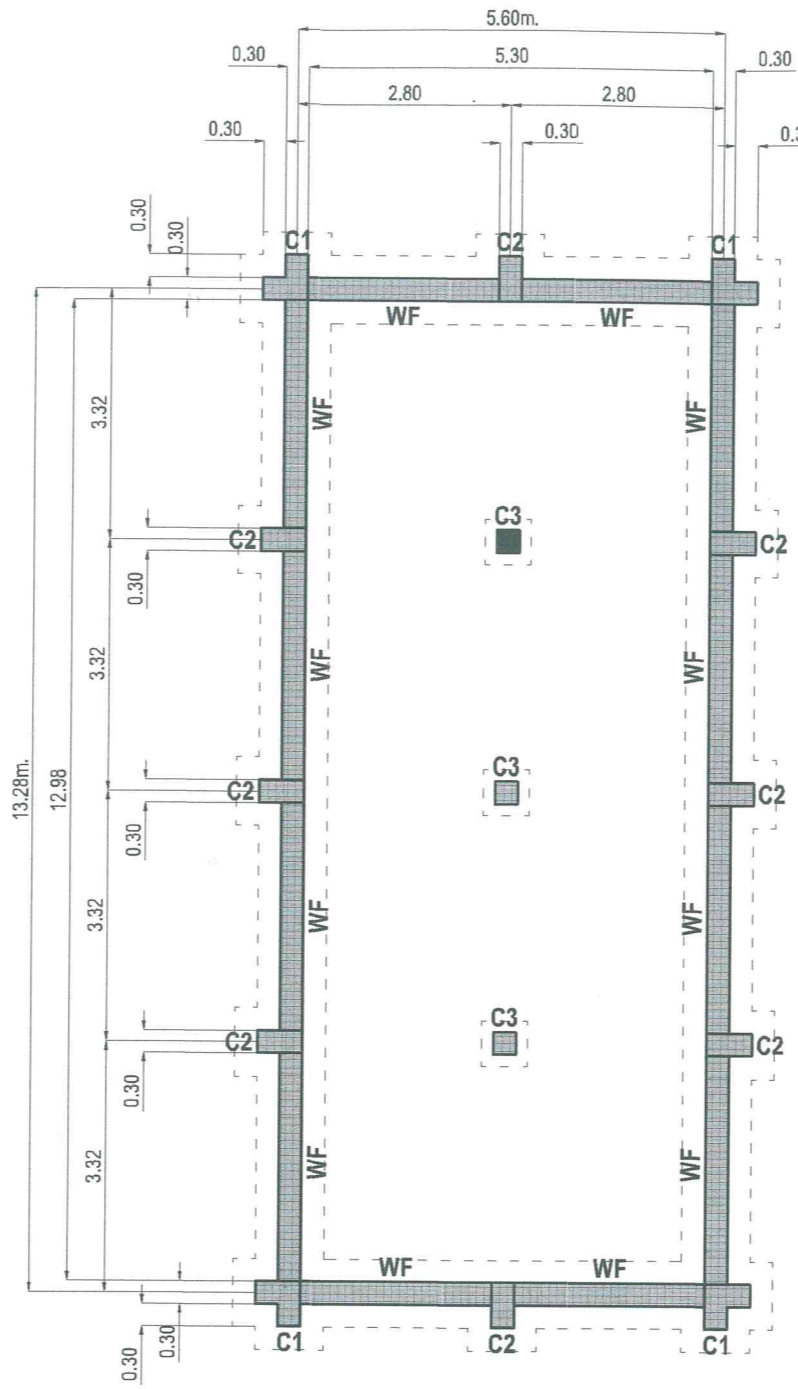

FOUNDATION PLAN

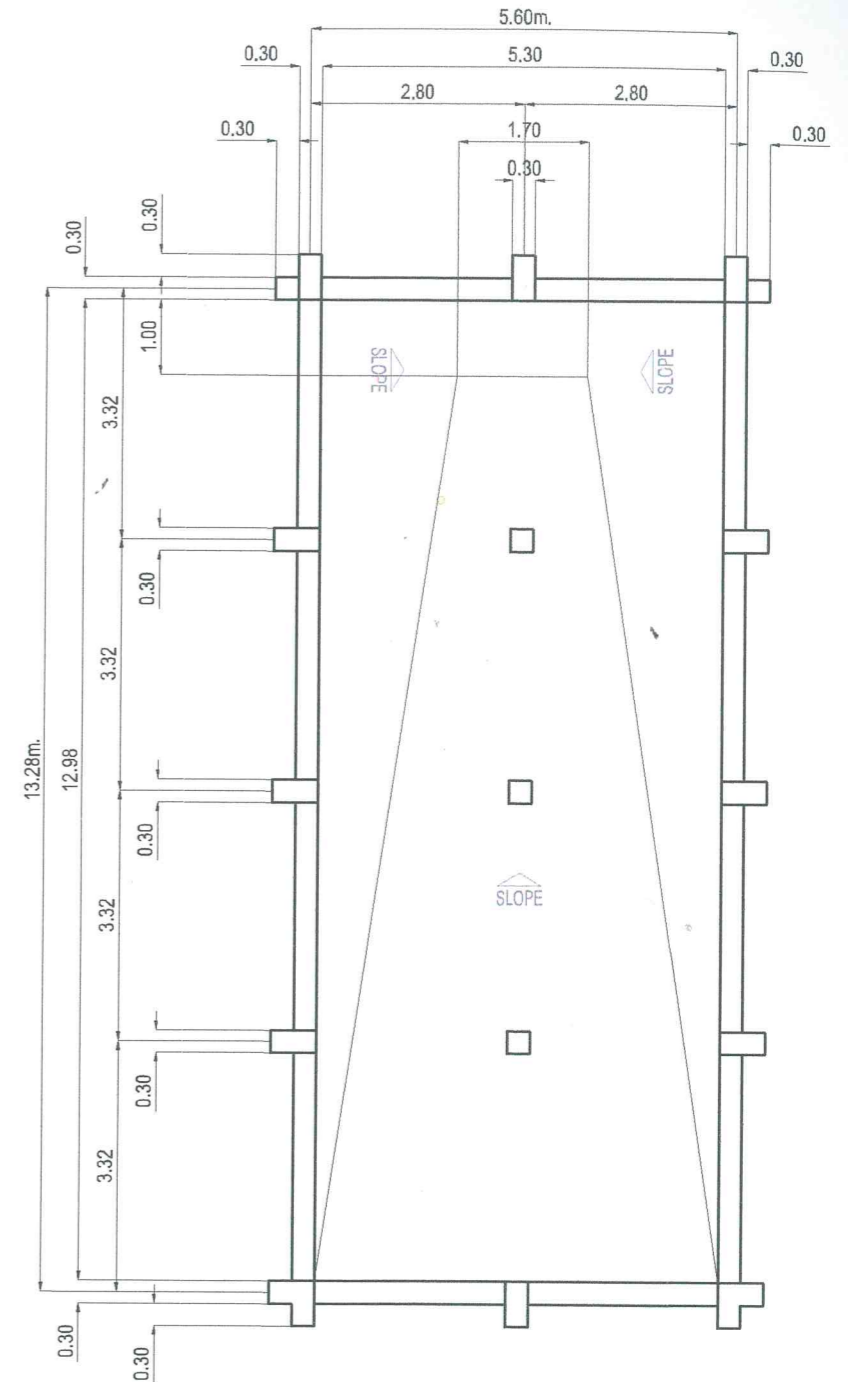


BOTTOM FLOOR PLAN

PROPOSED GROUND TANK

SCALE: 1:100 M.


REVISIONS				PROJECT:	DRAWN BY:	PREPARED BY:	REVIEWED BY:	SUBMITTED BY:	RECOMMENDING PROJECT IMPLEMENTATION:	APPROVED FOR PROJECT IMPLEMENTATION:	SHEET NO.
REV.	DATE	BY	DESCRIPTION								
				PROPOSED 300 CU. M. REINFORCED CONCRETE GROUND TANKS AT BALUNO & BANDERA-DULIAN FOR DUMALON WATER SYSTEM	ARTHUR A. REYES PRINCIPAL DRAFTSMAN - DESIGN DIVISION	BUNNY L. DAMPIOS SENIOR ENGINEER A - DESIGN DIVISION	REX D. SALE, JR. SUPERVISING ENGINEER A - DESIGN DIVISION	EDITO M. BAUTISTA, JR. OIC - DESIGN DIVISION	MARLI ACOSTA - DE FIESTA AGM - TECHNICAL SERVICES GROUP	REYNALDO R. CABILN GENERAL MANAGER	4
SHEET CONTENT:											

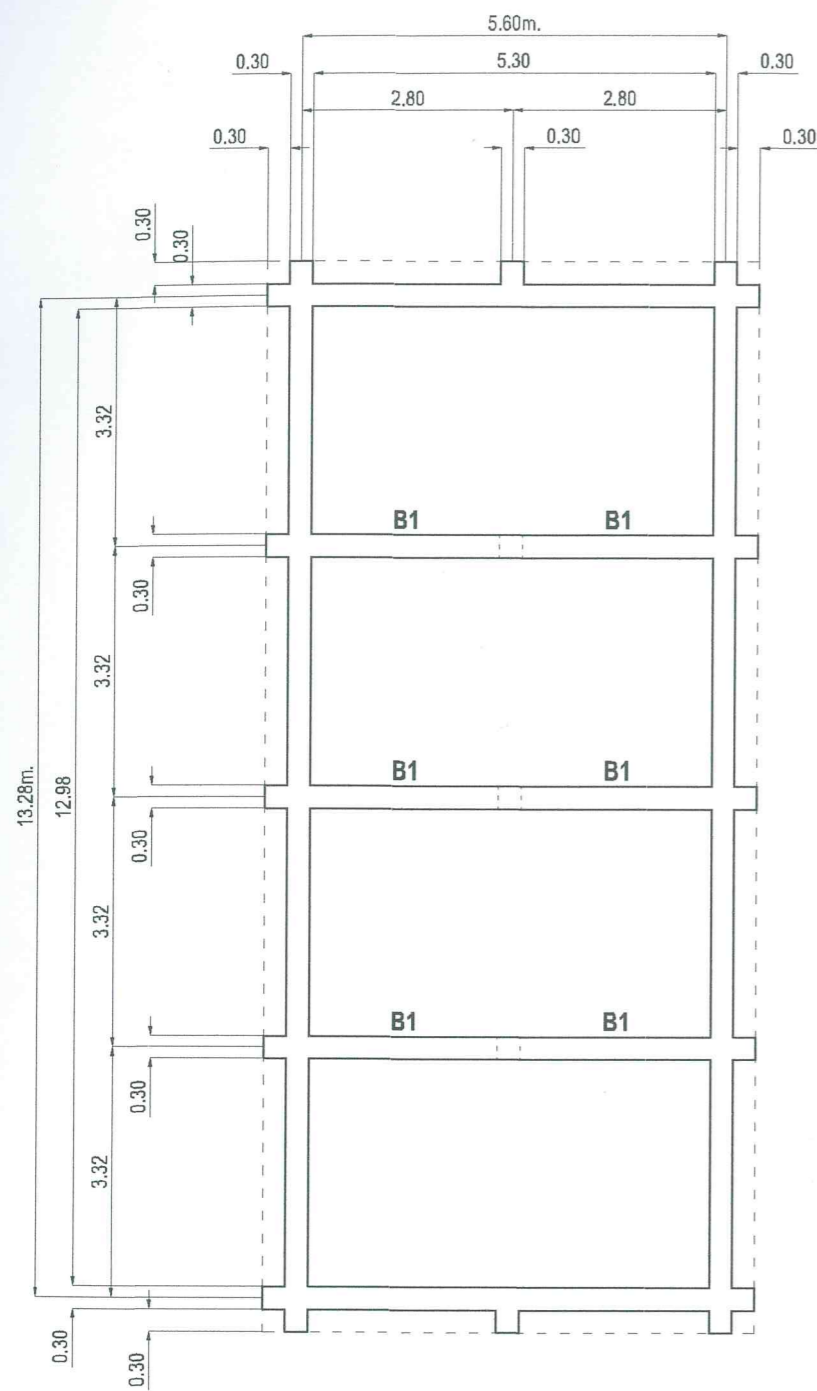

TOP FLOOR FRAMING PLAN

PROPOSED GROUND TANK


SCALE: 1:100 M.

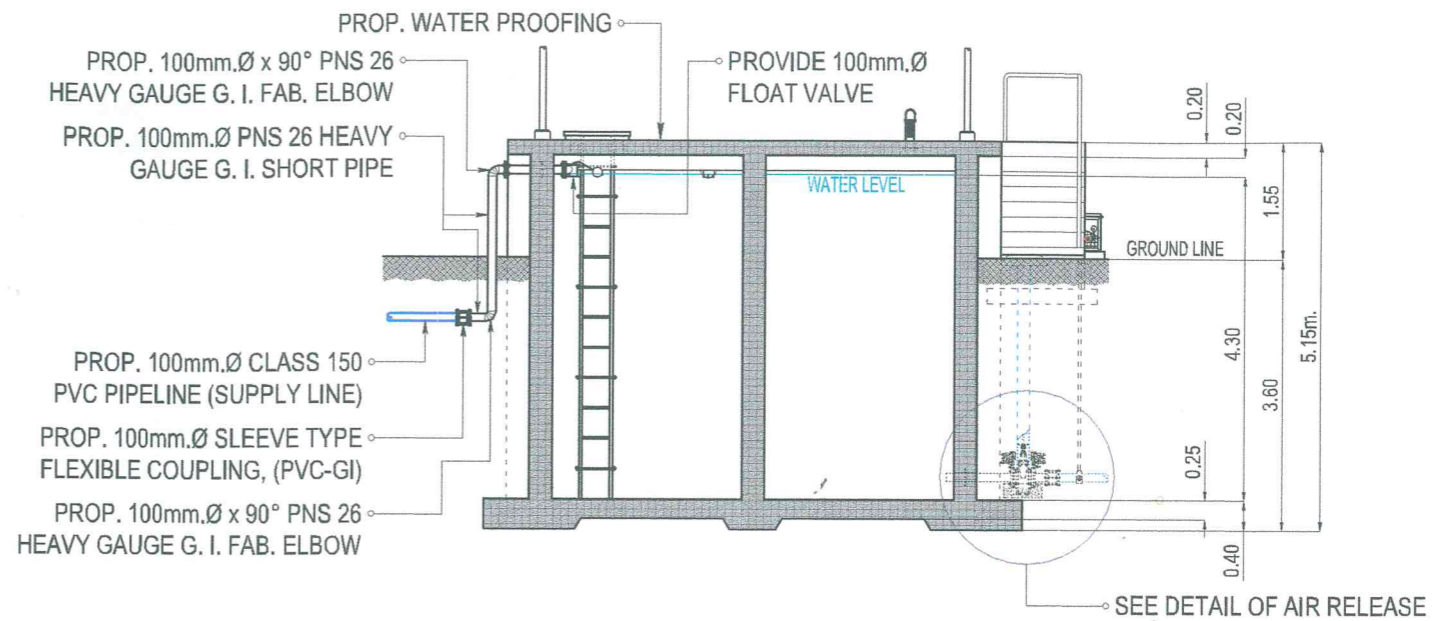

CROSS SECTION THRU A, BANDERA

SCALE: 1:100 M.

NOTE: PROVIDE TANK LEVEL SENSOR AT REINFORCED CONCRETE TANKS

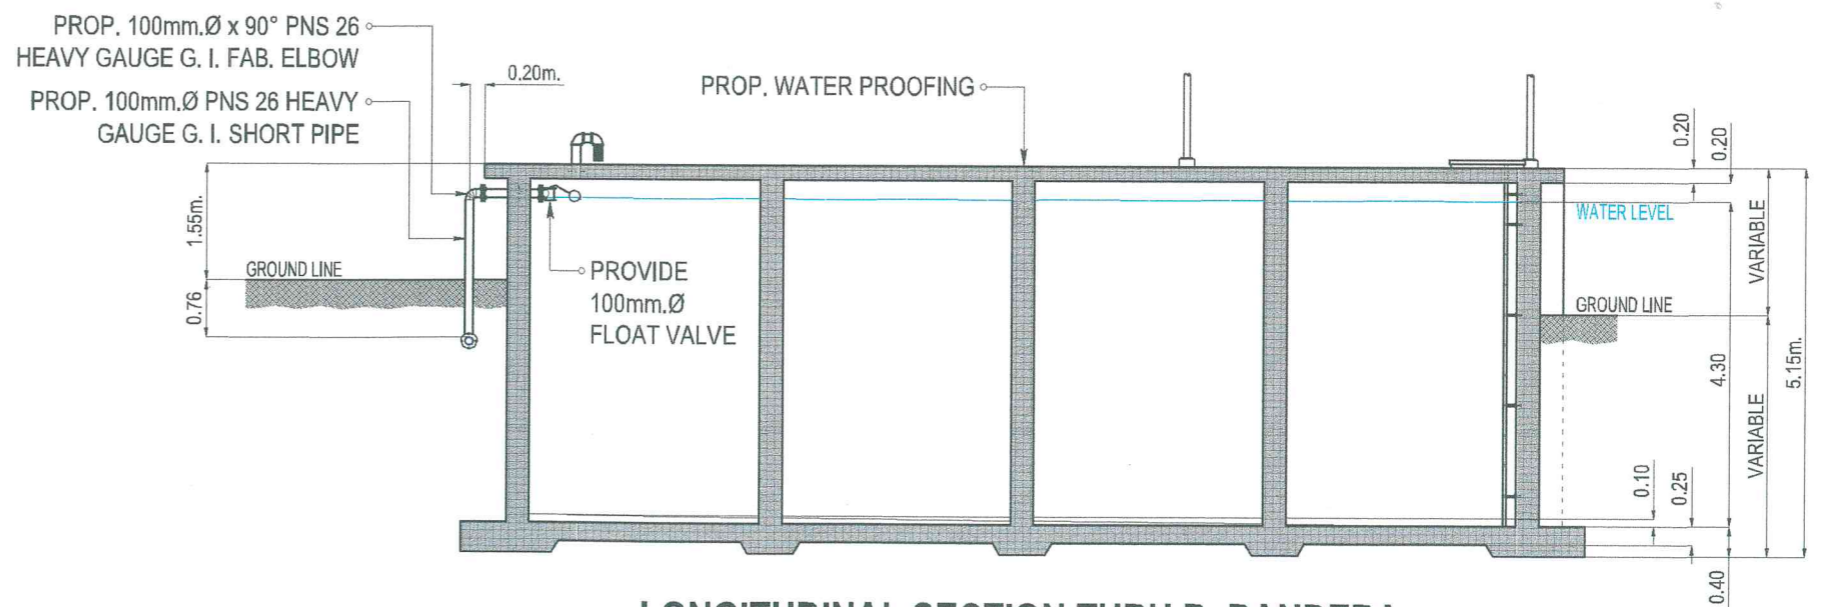

LONGITUDINAL SECTION THRU B, BANDERA

SCALE: 1:100 M.

	REVISIONS REV. DATE BY DESCRIPTION		PROJECT: PROPOSED 300 CU. M. REINFORCED CONCRETE GROUND TANKS AT BALUNO & BANDERA-DULJAN FOR DUMALON WATER SYSTEM	DRAWN BY: ARTHUR A. REYES PRINCIPAL DRAFTSMAN B - DESIGN DIVISION	PREPARED BY: BUNNY L. DAMPIOG SENIOR ENGINEER A - DESIGN DIVISION	REVIEWED BY: REX D. SALE, JR. SUPERVISING ENGINEER A - DESIGN DIVISION	SUBMITTED BY: EDITO M. BAUTISTA, JR. OIC - DESIGN DIVISION	RECOMMENDING PROJECT IMPLEMENTATION: MARLI ACOSTA - DE FIESTA AGM - TECHNICAL SERVICES GROUP	APPROVED FOR PROJECT IMPLEMENTATION: REYNALDO R. CABILIN GENERAL MANAGER	SHEET NO. 5
	SHEET CONTENT: AS INDICATED									