


**DETAIL OF AIR VENT**


SCALE: 1:10 M.

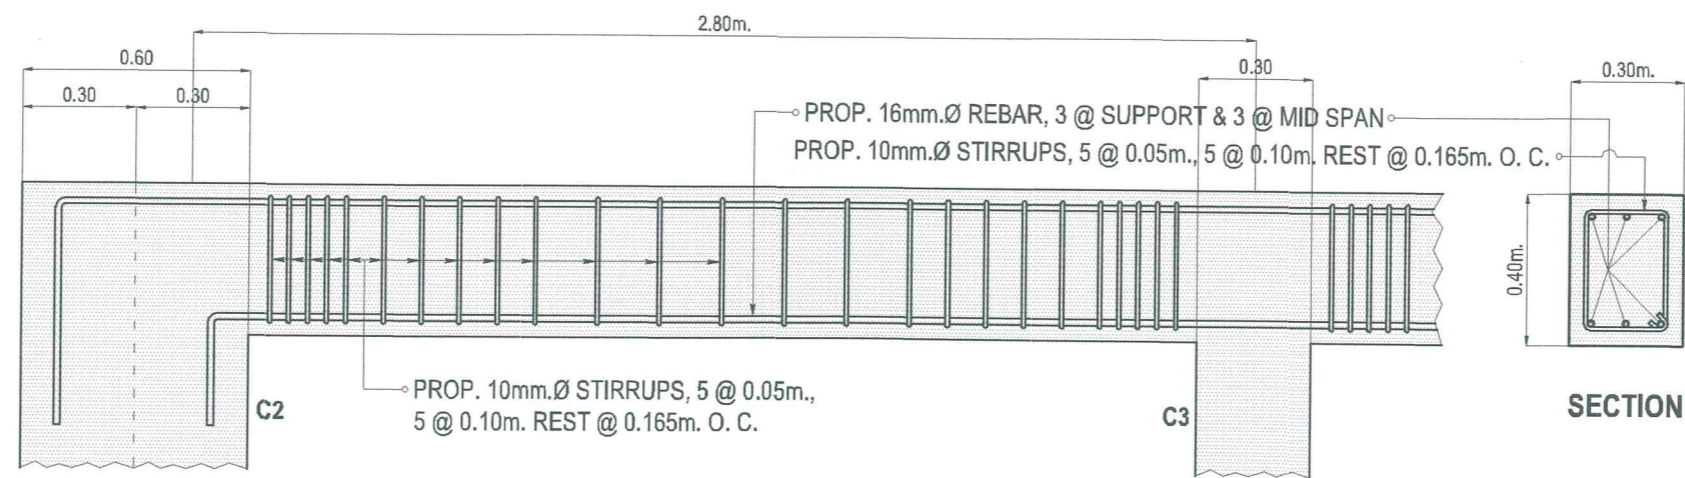



**DETAIL OF BEAM 1 (B1)**

SCALE: 1:20 M.

	<table border="1"> <thead> <tr> <th colspan="4">REVISIONS</th> </tr> <tr> <th>REV.</th> <th>DATE</th> <th>BY</th> <th>DESCRIPTION</th> </tr> </thead> <tbody> <tr> <td> </td> <td> </td> <td> </td> <td> </td> </tr> <tr> <td> </td> <td> </td> <td> </td> <td> </td> </tr> <tr> <td> </td> <td> </td> <td> </td> <td> </td> </tr> </tbody> </table>				REVISIONS				REV.	DATE	BY	DESCRIPTION													PROJECT: PROPOSED 300 CU. M. REINFORCED CONCRETE GROUND TANKS AT BALUNO & BANDERA-DULIAN FOR DUMALON WATER SYSTEM	DRAWN BY:  <b>ARTHUR A. REYES</b> PRINCIPAL DRAFTSMAN - DESIGN DIVISION	PREPARED BY:  <b>BUNNY L. DAMPICO</b> SENIOR ENGINEER A - DESIGN DIVISION	REVIEWED BY:  <b>REX D. SALE, JR.</b> SUPERVISING ENGINEER A - DESIGN DIVISION	SUBMITTED BY:  <b>EDITO M. BAUTISTA, JR.</b> OIC - DESIGN DIVISION	RECOMMENDING PROJECT IMPLEMENTATION:  <b>MARLI ACOSTA - DE FIESTA</b> AGM - TECHNICAL SERVICES GROUP	APPROVED FOR PROJECT IMPLEMENTATION:  <b>REYNALDO R. CABILAN</b> GENERAL MANAGER	SHEET NO. 10
	REVISIONS																															
REV.	DATE	BY	DESCRIPTION																													
SHEET CONTENT: AS INDICATED																																

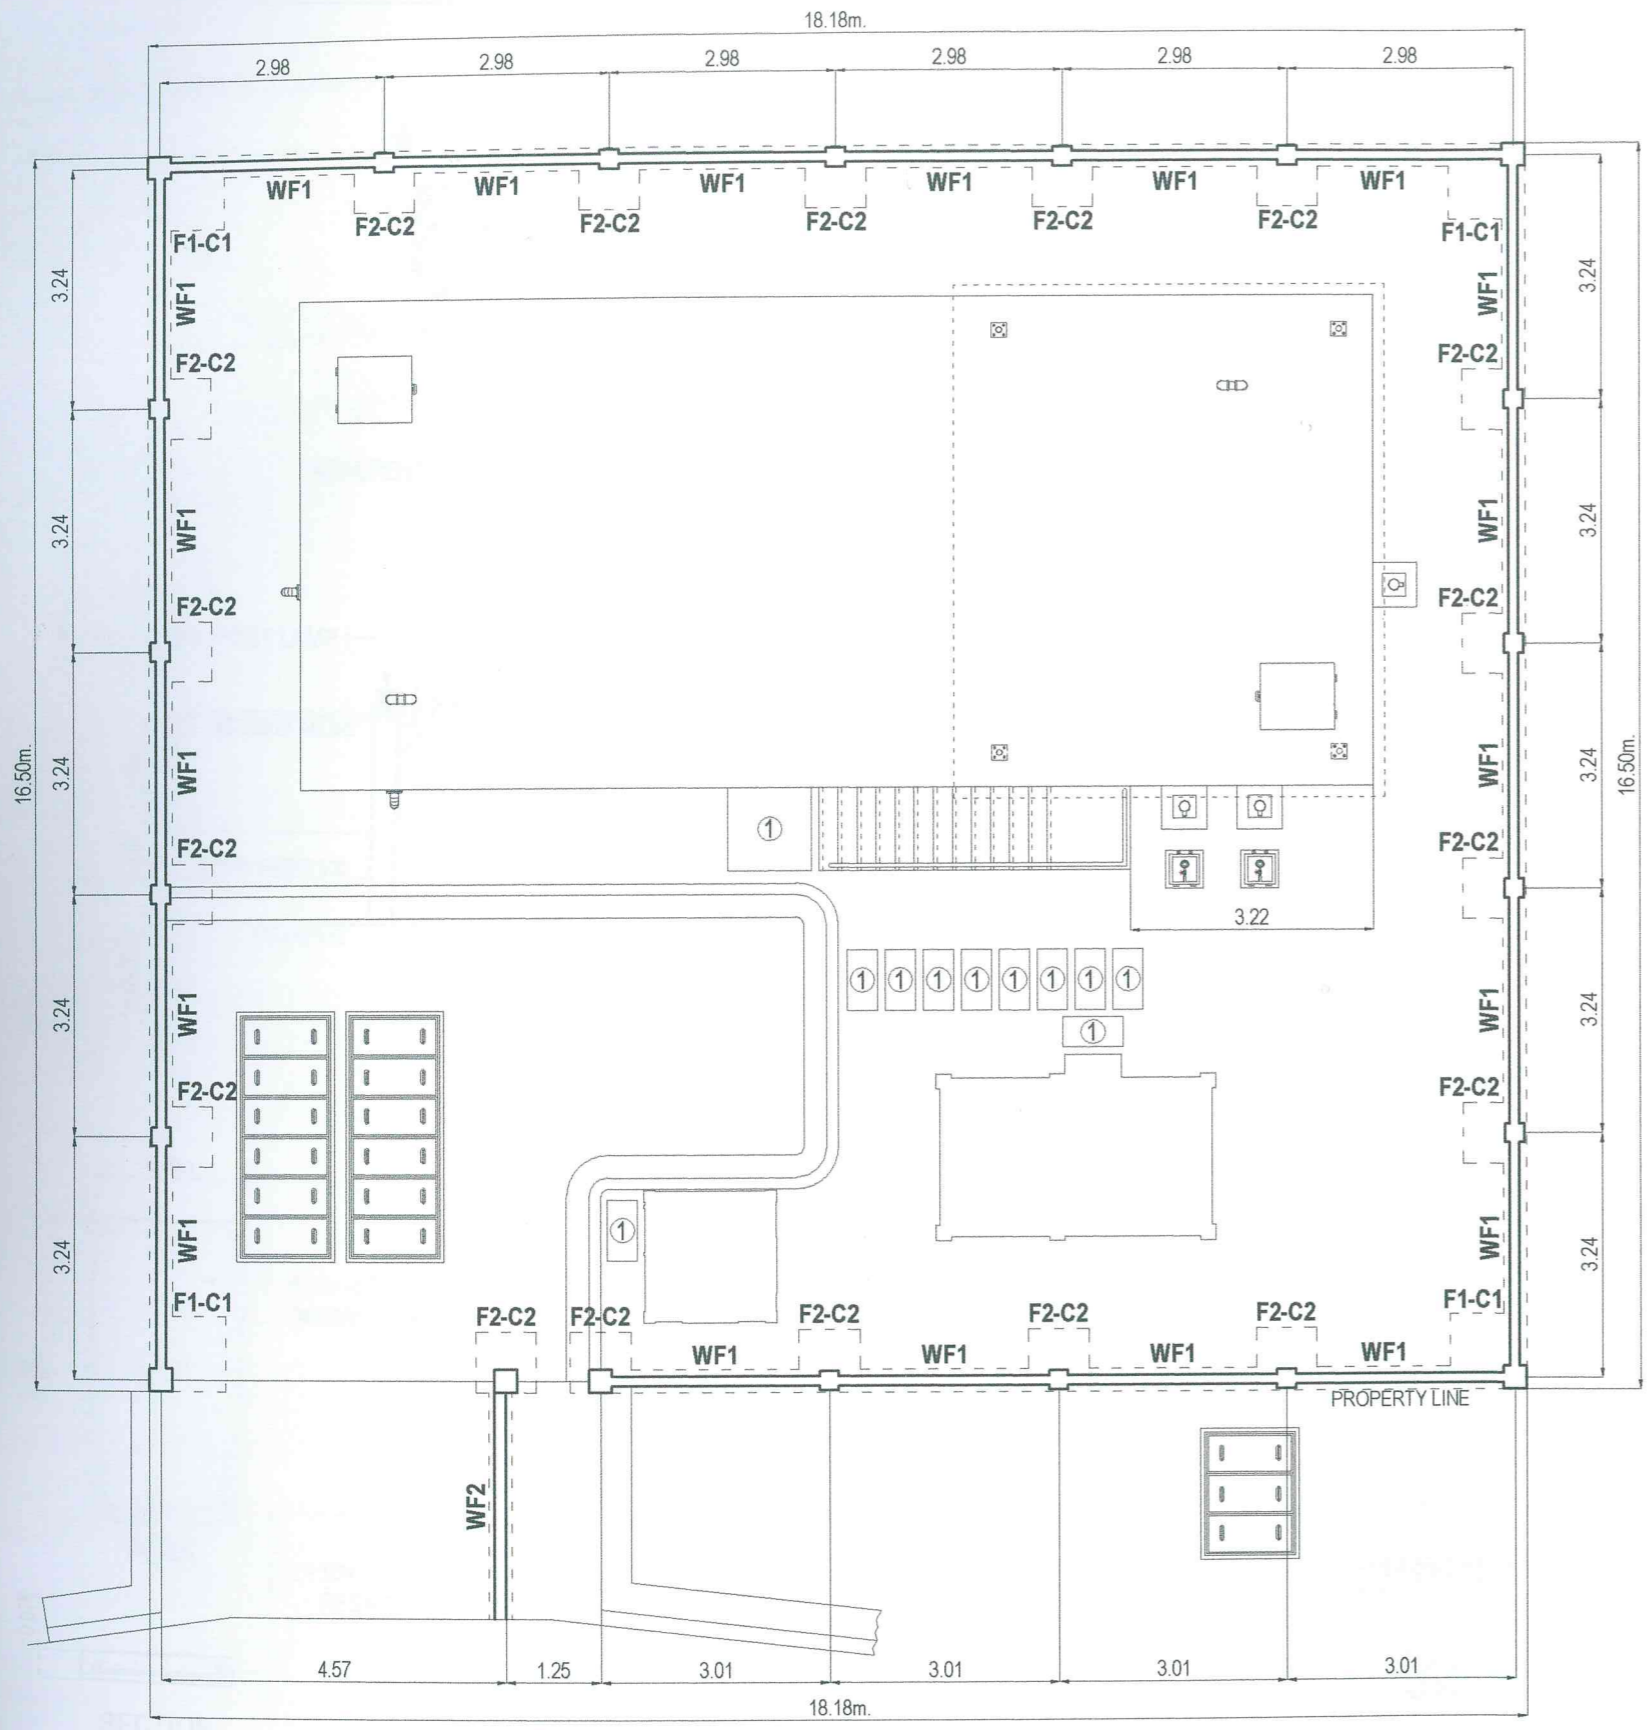

**PROP. FOUNDATION PLAN OF FENCE, BANDERA**  
SCALE: 1:100M.

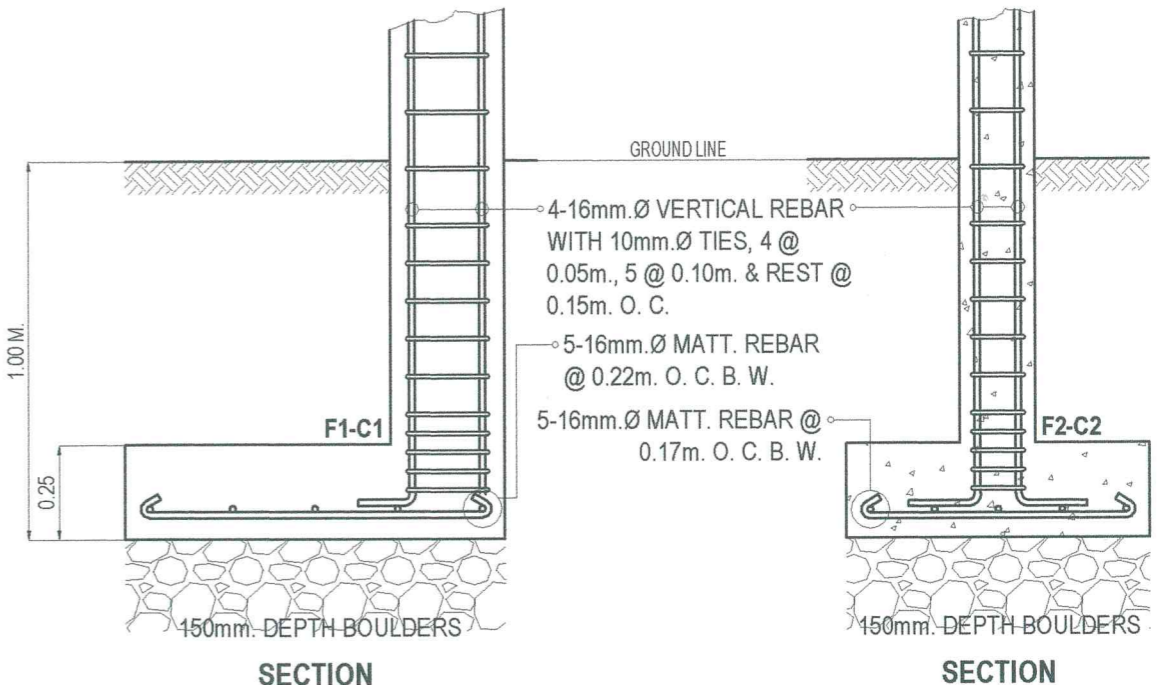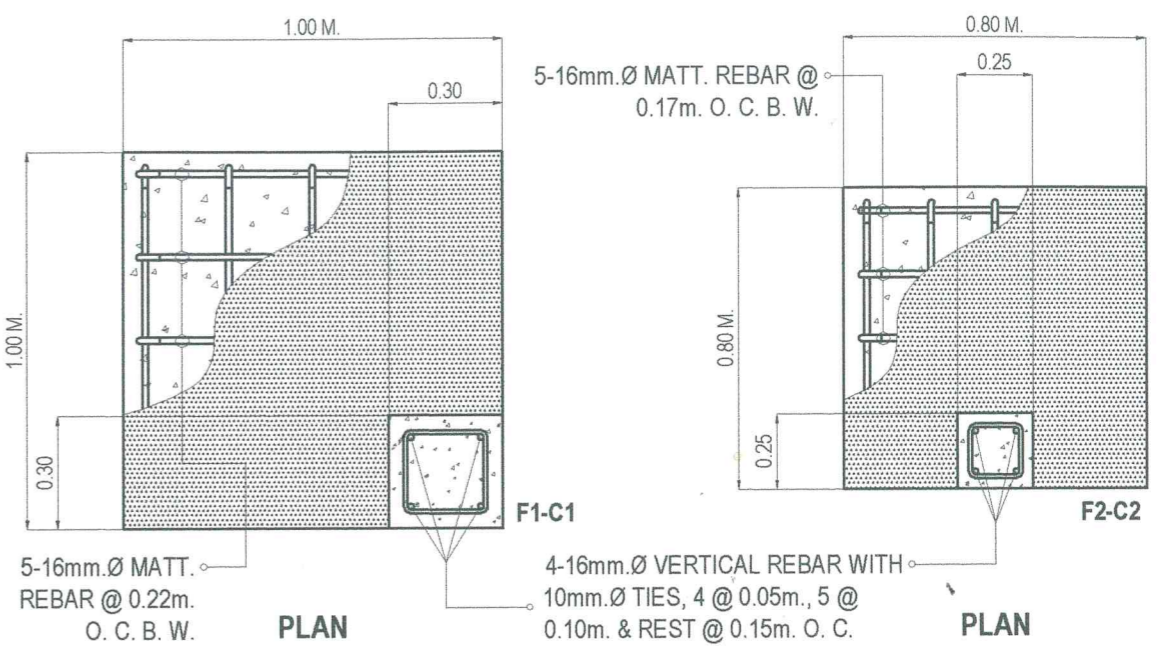

**DETAIL OF COLUMN & FOOTING**  
SCALE: 1:20 M.

	<table border="1"> <thead> <tr> <th>REV.</th> <th>DATE</th> <th>BY</th> <th>REVISIONS</th> <th>DESCRIPTION</th> </tr> </thead> <tbody> <tr> <td> </td> <td> </td> <td> </td> <td> </td> <td> </td> </tr> <tr> <td> </td> <td> </td> <td> </td> <td> </td> <td> </td> </tr> <tr> <td> </td> <td> </td> <td> </td> <td> </td> <td> </td> </tr> </tbody> </table>				REV.	DATE	BY	REVISIONS	DESCRIPTION																PROJECT: PROPOSED 300 CU. M. REINFORCED CONCRETE GROUND TANKS AT BALUNO & BANDERA-DULIAN FOR DUMALON WATER SYSTEM	DRAWN BY:  <b>ARTHUR A. REYES</b> PRINCIPAL DRAFTSMAN - DESIGN DIVISION	PREPARED BY:  <b>BUNNY L. DAMPIOS</b> SENIOR ENGINEER A - DESIGN DIVISION	REVIEWED BY:  <b>REX D. SALE, JR.</b> SUPERVISING ENGINEER A - DESIGN DIVISION	SUBMITTED BY:  <b>EDITO M. BAUTISTA, JR.</b> OIC - DESIGN DIVISION	RECOMMENDING PROJECT IMPLEMENTATION:  <b>MARLI ACOSTA DE FIESTA</b> AGM - TECHNICAL SERVICES GROUP	APPROVED FOR PROJECT IMPLEMENTATION:  <b>REYNALDO R. CABILAN</b> GENERAL MANAGER	SHEET NO. <b>11</b>
	REV.	DATE	BY	REVISIONS	DESCRIPTION																											
SHEET CONTENT: AS INDICATED																																